


EAST ELEVATION

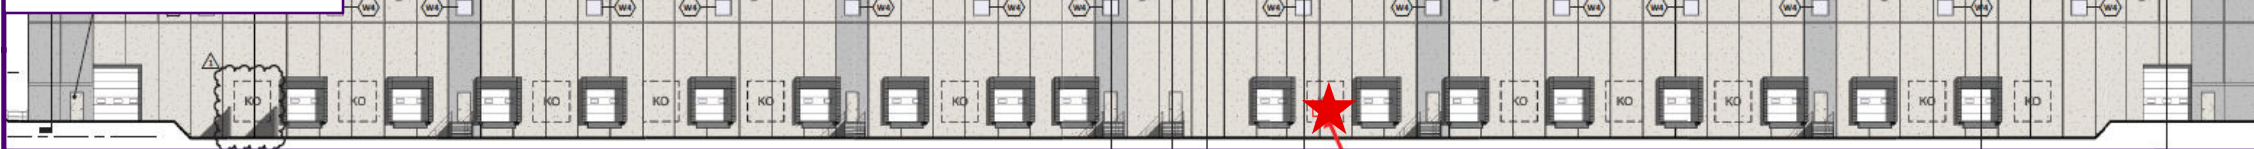


95TH AVE N
32'
24'

(COUNTY RD 202)

ZACHARY LN N

S 89 1970 3" PE CL-6

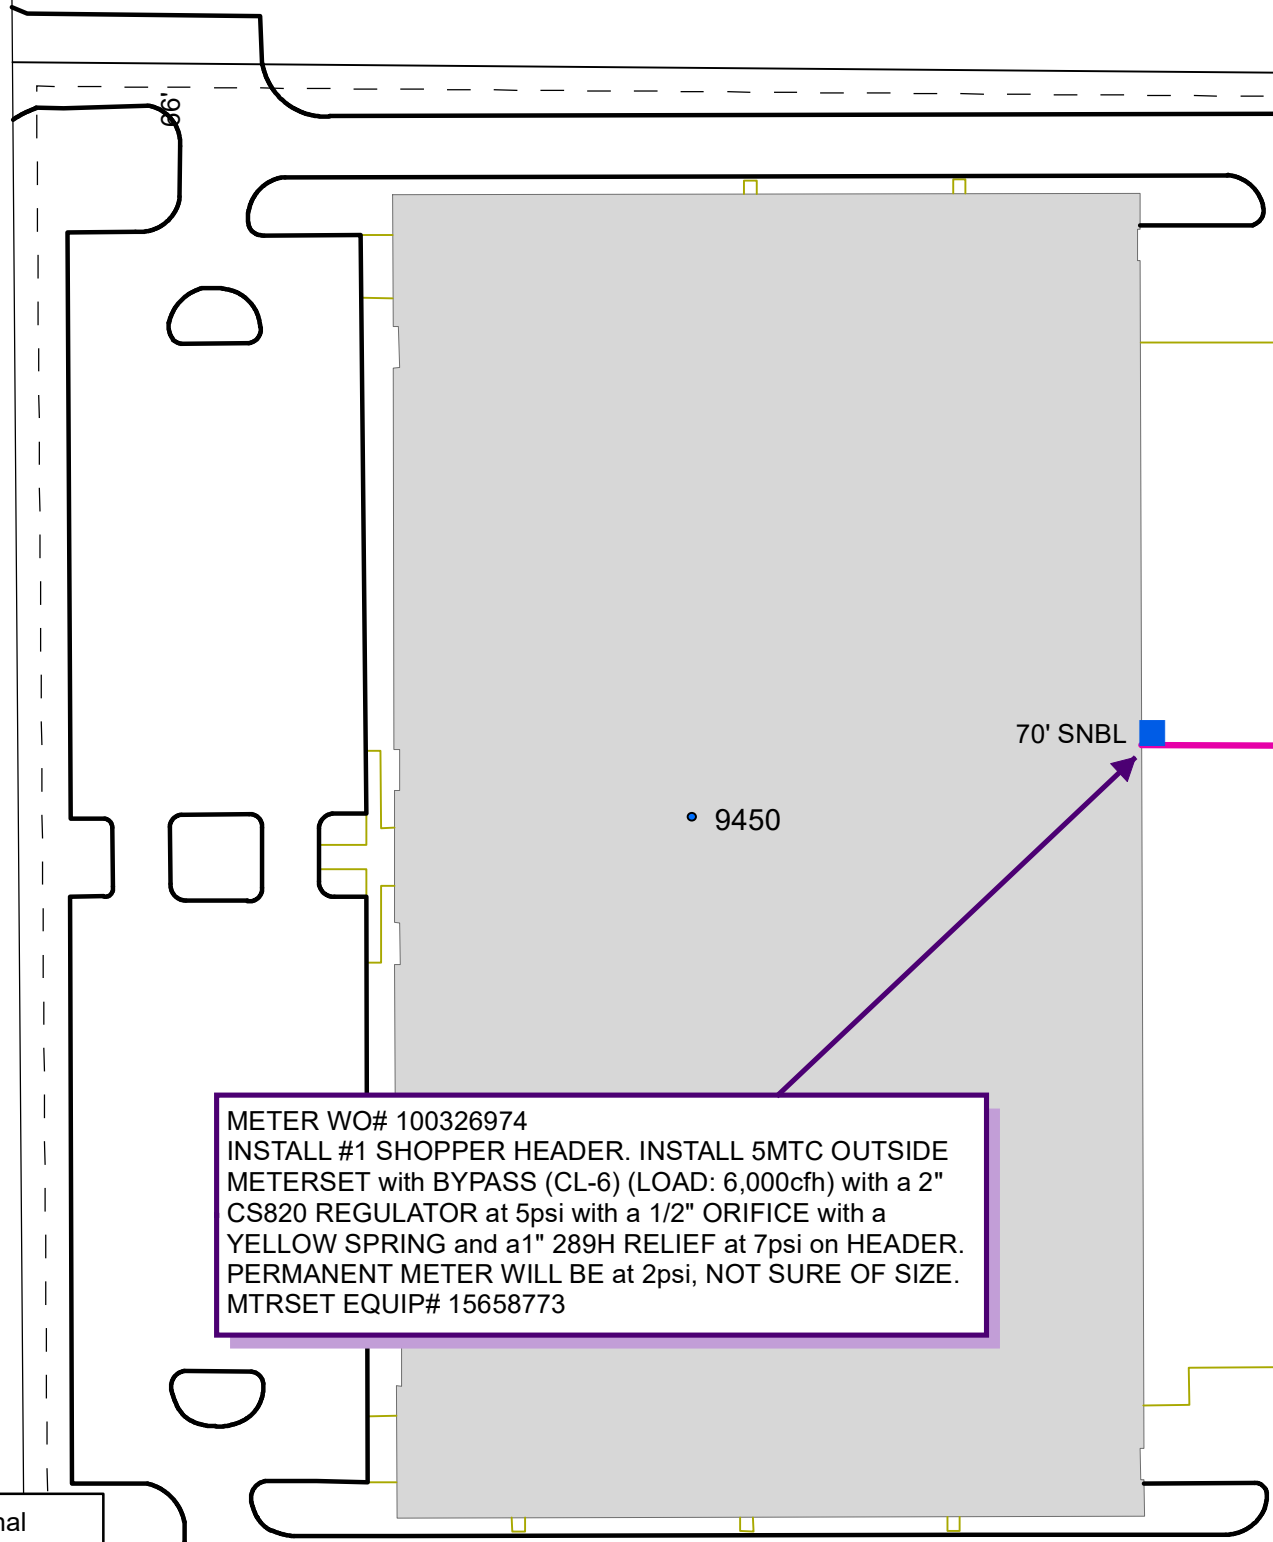

SERVICE WO# 100326975
 INSTALL 1-1/4" X 1-1/4" IPS PE SERVICE TEE with 3/4" TAP. INSTALL 1-1/4" POLYVALVE IN BLVD.
 REDUCE UP TO 2" AND INSTALL 500' OF 2" IPS PE CL-6 SERVICE LINE with 1-1/4" MPT x 1-1/4" IPS ANODELESS RISER with BYPASS, with SLEEVE.
 POLYVALVE EQUIP# 15683514
 SERVICE EQUIP# 69968214

METER WO# 100326974
 INSTALL #1 SHOPPER HEADER. INSTALL 5MTC OUTSIDE METERSET with BYPASS (CL-6) (LOAD: 6,000cfh) with a 2" CS820 REGULATOR at 5psi with a 1/2" ORIFICE with a YELLOW SPRING and a 1" 289H RELIEF at 7psi on HEADER. PERMANENT METER WILL BE at 2psi, NOT SURE OF SIZE. MTRSET EQUIP# 15658773

CUSTOMER APPROVAL OF DESIGN I/C:

SIGNATURE: _____

PRINTED NAME: _____ DATE: _____

Please review CenterPoint Energy design for installing Natural Gas to your facility. Verify the route of the Service Line and Meter Location on the building. If there is a conflict please contact the Designer and Sales Rep as shown in the Title Block. Before a natural gas service line can be installed, you must clearly mark all privately-owned underground facilities including: septic tanks, drain fields, sewer lines, water wells, sprinkler systems, invisible fences, electric lines and pipelines. CenterPoint Energy and its representatives are not responsible for damage to these items if they are not clearly marked at time of installation.

Project area cleared for internal impacts. Pipe being removed is unregulated for disposal if coating does not exist or is non-asbestos. Refer to CNP Construction and Service Manual CS-B-1.110, CS-B-1.330, and CS-B-1.100, for pipe to be abandoned.



PROPRIETARY AND CONFIDENTIAL

100326975
 M52900 MAPLE GROVE
 ONE CALL:
 Hennepin
 *SW12 T119/R22
 *= this Page

LEGEND:

- ACTIVE
- DESIGNED
- PROPOSED
- ABANDONED
- A ABANDONED

- Interruptible
- Existing
- Normal
- Future
- Proposed

Address: 9450 Zachary Ln N
 Customer: ZDC Partners
 Contact Person: Abel Hein
 Contact Phone: 612-32-5739
 Sales Rep: Grant Dhein
 Sales Rep Phone: 612-861-8455
 Construction Hotline: 612-321-5310
 Copies To Pipeline Integrity: No
 Curb Valve: No
 Copies to Corrosion: No
 Corrosion Approval: N/A
 Follow Internal Pipe Sampling Requirements? No
 Permits: Yes - Hennepin County
 Requested Install Date: 11/21/2021

Approval: _____

PROJECT DESCRIPTION:
 ZACHARY DISTRIBUTION CTR

DESIGNER: Wendy Seidl
 PHONE #: 612-321-5476
 DRAWN BY: Wendy Seidl
 DESIGN DATE: 10/28/2021

Revised Print
 Destroy All Others
 Revision History
 Date:
 Description:
 Design Approval:

IC Services
 SCAN DATE: _____

1" : 80'
 SHEET 1 OF 1

DESIGNER EXPRESS DESIGN
 12/15/2021 4:08:45 PM