


SOUTH ELEVATION



PROPRIETARY AND CONFIDENTIAL

100513720
 M52900 MAPLE GROVE
 ONE CALL:
 Hennepin
 *NW25 T119/R22
 *NE26 T119/R22
 * = this Page

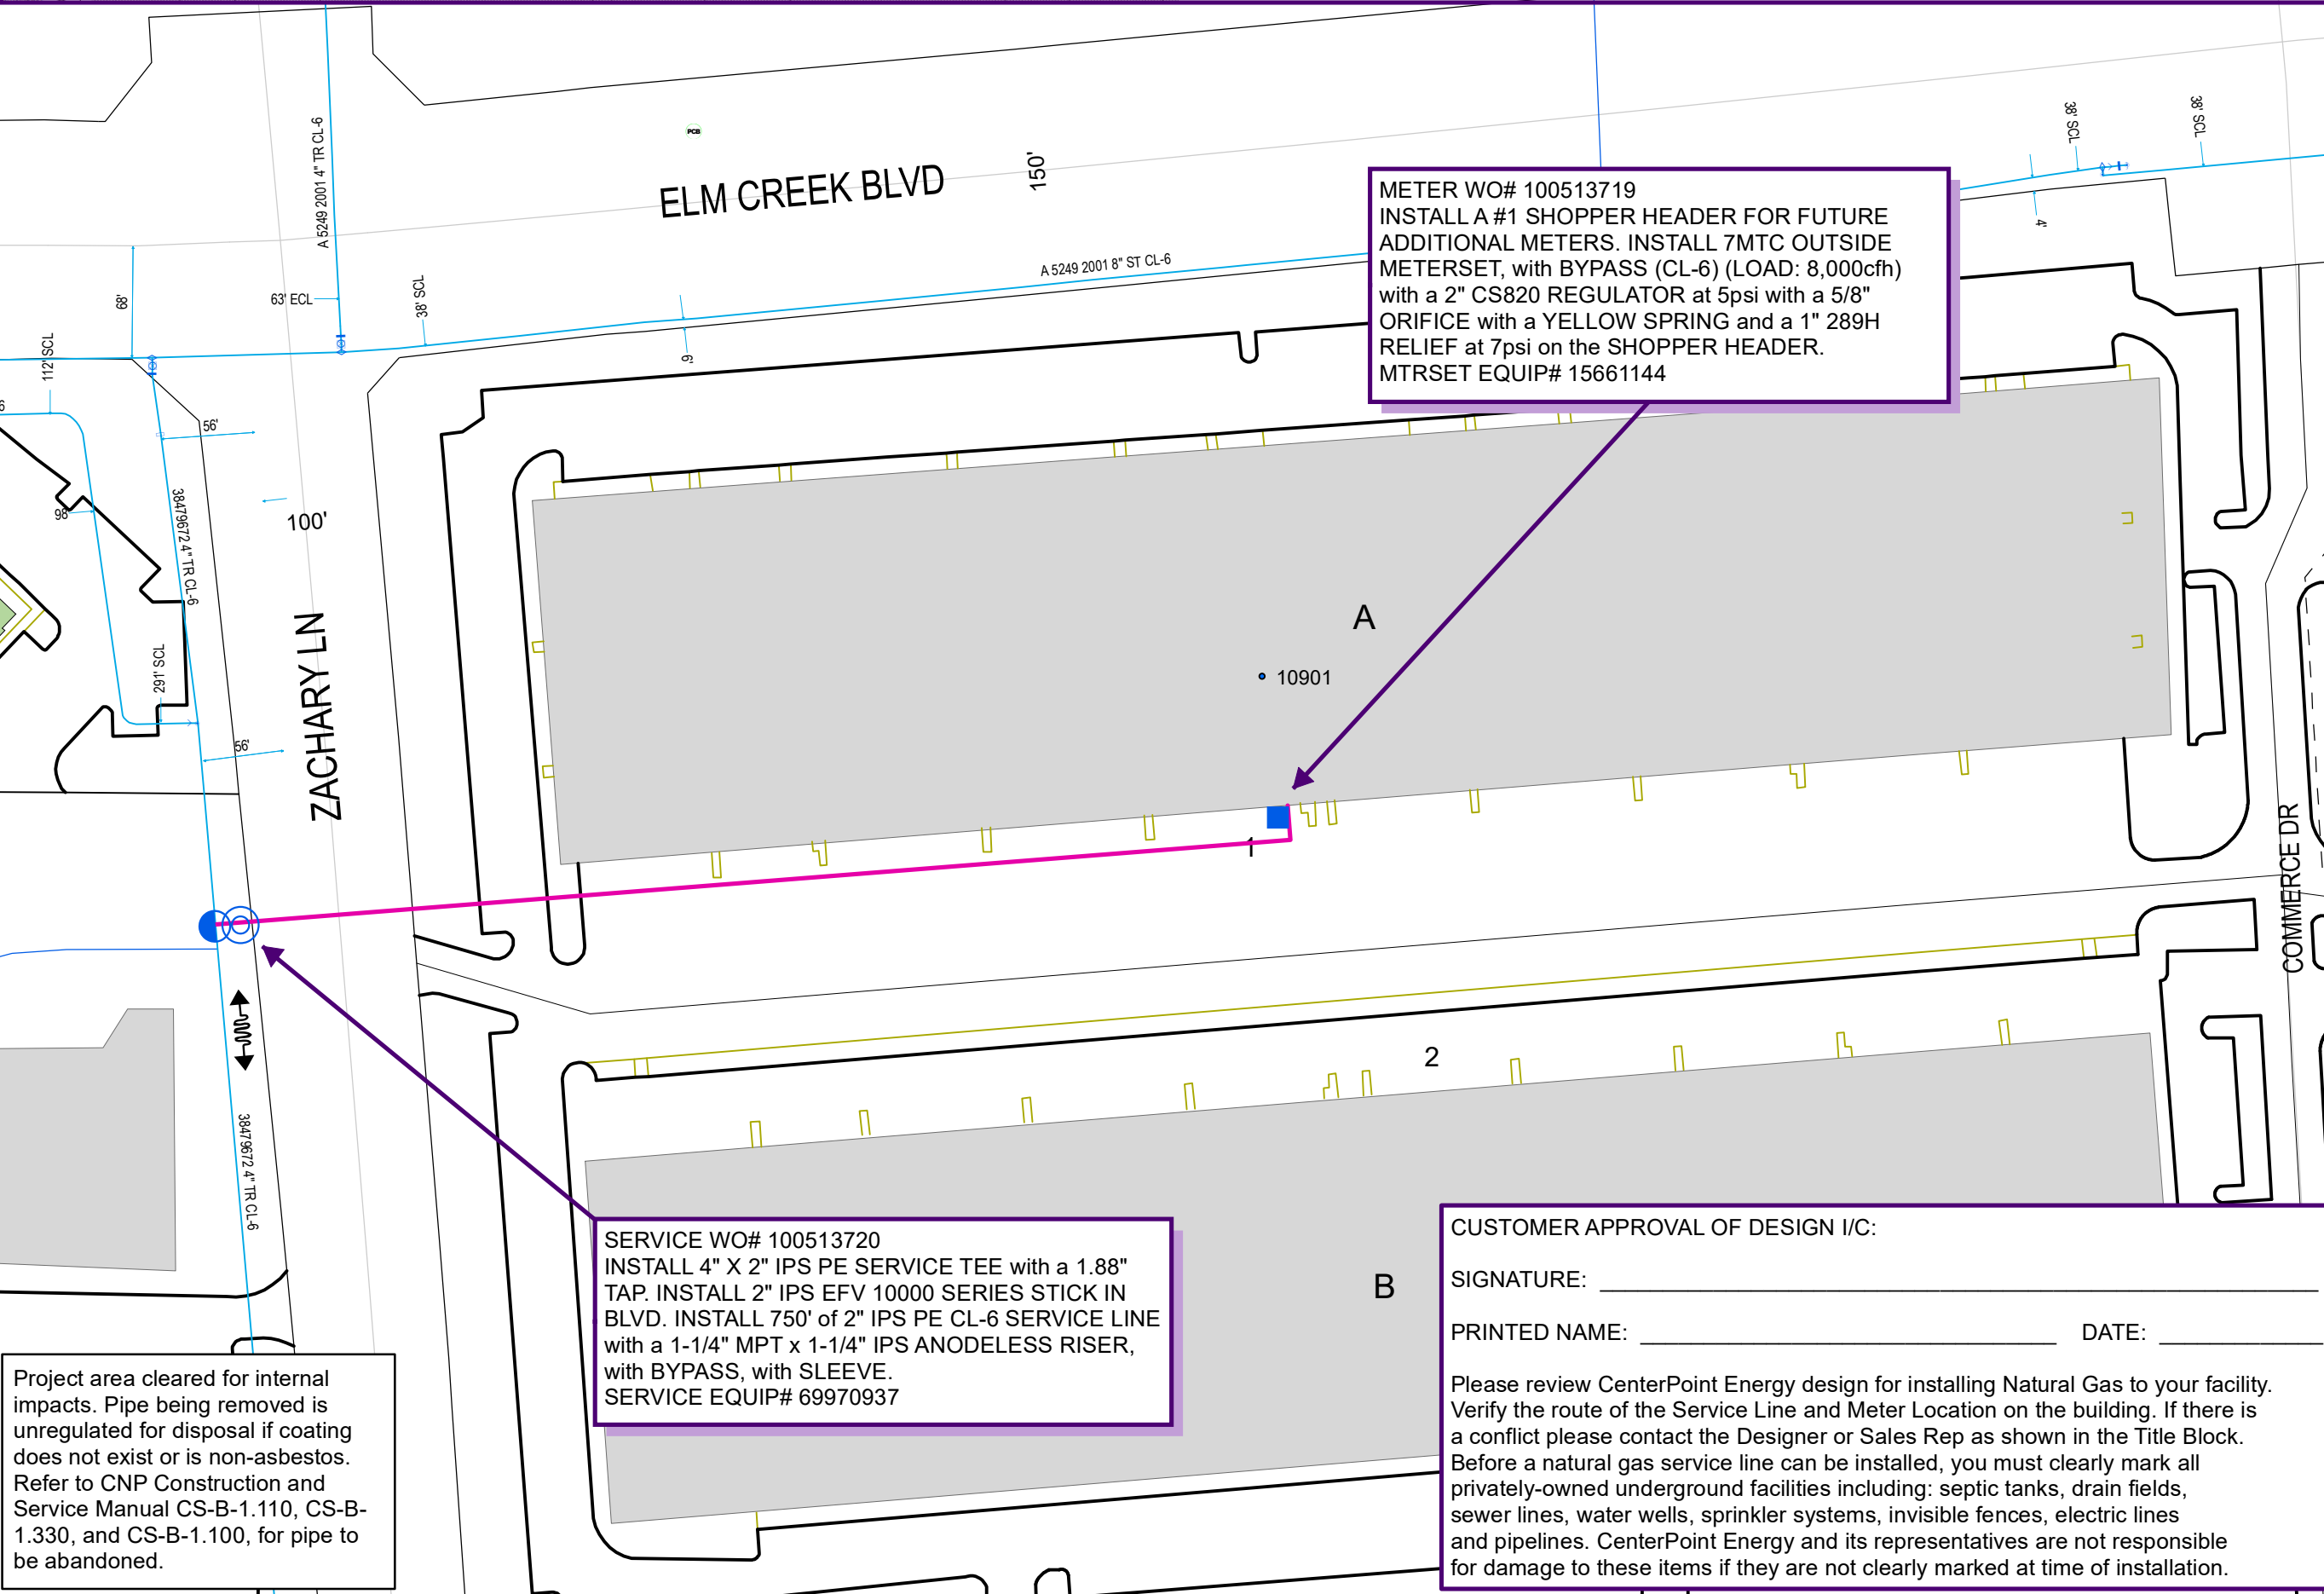

METER WO# 100513719
 INSTALL A #1 SHOPPER HEADER FOR FUTURE ADDITIONAL METERS. INSTALL 7MTC OUTSIDE METERSET, with BYPASS (CL-6) (LOAD: 8,000cfh) with a 2" CS820 REGULATOR at 5psi with a 5/8" ORIFICE with a YELLOW SPRING and a 1" 289H RELIEF at 7psi on the SHOPPER HEADER. MTRSET EQUIP# 15661144

SERVICE WO# 100513720
 INSTALL 4" X 2" IPS PE SERVICE TEE with a 1.88" TAP. INSTALL 2" IPS EFV 10000 SERIES STICK IN BLVD. INSTALL 750' of 2" IPS PE CL-6 SERVICE LINE with a 1-1/4" MPT x 1-1/4" IPS ANODELESS RISER, with BYPASS, with SLEEVE. SERVICE EQUIP# 69970937

CUSTOMER APPROVAL OF DESIGN I/C:
 SIGNATURE: _____
 PRINTED NAME: _____ DATE: _____
 Please review CenterPoint Energy design for installing Natural Gas to your facility. Verify the route of the Service Line and Meter Location on the building. If there is a conflict please contact the Designer or Sales Rep as shown in the Title Block. Before a natural gas service line can be installed, you must clearly mark all privately-owned underground facilities including: septic tanks, drain fields, sewer lines, water wells, sprinkler systems, invisible fences, electric lines and pipelines. CenterPoint Energy and its representatives are not responsible for damage to these items if they are not clearly marked at time of installation.

- LEGEND:**
- ACTIVE
 - DESIGNED
 - PROPOSED
 - ABANDONED
 - A ABANDONED
 - Interruptible
 - Existing
 - Normal
 - Future
 - Proposed

Address: 10901 Elm Creek Blvd
 Customer: Arbor Lake Business Park, Bldg A
 Contact Person: Abel Hein
 Contact Phone: 612-328-5739
 Sales Rep: Grant Dhein
 Sales Rep Phone: 612-861-8455
 Construction Hotline: 612-321-5310
 Copies To Pipeline Integrity: No
 Curb Valve: No
 Copies to Corrosion: No
 Corrosion Approval: N/A
 Follow Internal Pipe Sampling Requirements? No
 Permits: Yes - City Of Maple Grove
 Requested Install Date: 12/05/2021
 Approval: _____

PROJECT DESCRIPTION:
 ARBOR LAKES BUSINESS PARK

DESIGNER: Wendy Seidl
 PHONE #: 612-321-5476
 DRAWN BY: Wendy Seidl
 DESIGN DATE: 12/9/2021

Revised Print
 Destroy All Others
 Revision History
 Date:
 Description:
 Design Approval:

IC Services
 SCAN DATE: 1" : 100'
 SHEET 1 OF 1

DESIGNER EXPRESS DESIGN
 12/10/2021 1:41:51 PM

Project area cleared for internal impacts. Pipe being removed is unregulated for disposal if coating does not exist or is non-asbestos. Refer to CNP Construction and Service Manual CS-B-1.110, CS-B-1.330, and CS-B-1.100, for pipe to be abandoned.